


- NOTES :**
1. ALL OUTDOOR UNITS AND TREATED FRESH AIR UNITS SHALL BE INSTALLED IN A SUITABLE LOCATION ON ROOF.
 2. THE REFRIGERANT HEADER PIPES, CONDENSATE DRAIN PIPES AND TREATED FRESH AIR HEADER DUCT SHALL RUN ALONG CORRIDOR.
 3. CONDENSATE DRAIN PIPES SHALL BE TERMINATED IN NEAREST TOILETS.
 4. LOCATIONS OF CASSETTE UNITS AND SUPPLY AIR GRILLES SHALL BE COORDINATED WITH FURNITURE LAYOUT.
 5. LOCATIONS OF CASSETTE UNITS AND SUPPLY AIR GRILLES SHALL BE COORDINATED WITH LIGHTING AND FIRE FIGHTING SPRINKLERS.
 6. RETURN AIR SHALL BE TAKEN OVER ROOM FALSE CEILING THROUGH 50mm SLIT AROUND FALSE CEILING.
 7. TREATED FRESH AIR SHALL BE SUPPLIED OVER FALSE CEILING IN EACH ROOM.
 8. ALL INDOOR UNITS WILL BE OPERATED BY SEPARATE HAND HELD REMOTE UNIT.
 9. FALSE CEILING HEIGHT IS 3M.

FOR TENDER ONLY

- NOTES:**
1. All dimensions are in millimetres and levels are in metres.
 2. Do not scale the drawing.

NORTH :

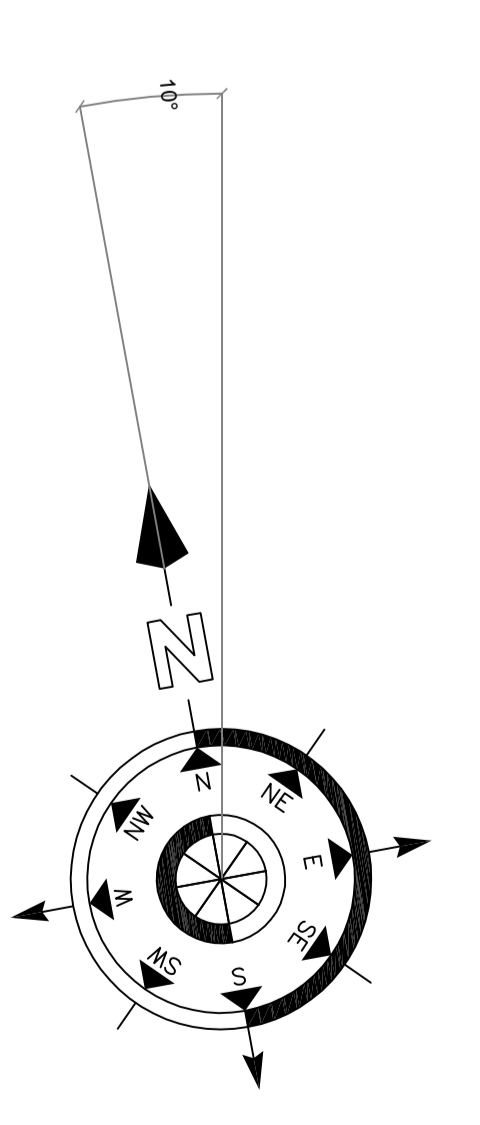

SCHEDULE OF OPENINGS

S. NO.	DISCRPTION	SIZE
1.	MD - MAIN DOOR (DOUBLE SHUTTER)	1500 X 2600
2.	D1 - DOOR	1200 X 2600
3.	D1 - DOOR	1200 X 2100
4.	D2 - DOOR	1000 X 2100
5.	D3 - DOOR	750 X 2100
6.	W - WINDOW	2000 X 1650
7.	W1 - WINDOW	1200 X 1650
8.	KW - WINDOW	1200 X 900
9.	V - VENTILATOR	1200 X 600
10.	V1 - VENTILATOR	600 X 600

REFERENCE DRAWINGS :

Revn.	Description	Date	Signature

Client : VISAKHAPATNAM PORT LOGISTICS PARK LIMITED.
(A BALMER LAWRIE - VISAKHAPATNAM PORT TRUST JV)

Project : MULTI MODAL LOGISTIC HUB AT VIZAG
EXIM. ADMIN BLOCK

Title : AIR CONDITIONING SYSTEM LAYOUT
GROUND FLOOR PLAN

Consultants :	
<p>aarvee associates architects engineers & consultants pvt ltd. Ravula Reddypally, Singar Colony Main Rd., Hyderabad-52, India Tel: +91-40-2373833, fax: +91-40-2373877 e-mail: aarvee@aarvee.net, Web: www.aarvee.net</p>	Scale Not to Scale Designed Drawn Lathika Checked Approved
Dwg. No.	Sheet No.
	Date 18-03-2017